



ADDENDUM NO. 01

PROJECT:

**Desmond Middle School
Locker Room HVAC**
Madera Unified School District

Date: 10/12/2023
NET POSITIVE Project No.: 1334
District Project No.: N/A
DSA File No.: N/A
DSA Appl. No.: N/A

The following additions, deletions and revisions to the plans, specifications and Addenda shall become a part of the plans and specifications. It is the responsibility of the General Contractor to submit the information contained in this addendum to all subcontractors and suppliers. The Bidder shall acknowledge receipt of the Addendum in the Bid Proposal. (Addendum number of pages: **1** pages + **1** attachments = **3** total pages).

DRAWINGS:

Section A, Desmond Middle School:

AD1-01: DRAWINGS, SHEET M501 –Demo and New Roof Plan, revise as follows:

- A. Remove Drawings Sheet No. M501 in its entirety and replace with Addenda Drawing No. M501 AD01-01.

DRAWINGS, SHEET M800 –Mechanical / Plumbing Details, revise as follows:

- A. Remove Drawings Sheet No. M800 in its entirety and replace with Addenda Drawing No. M800 AD01-01.


ATTACHMENTS:

ITEM #01

END OF ADDENDUM NO. 01

Jon Schlundt, P.E.
Engineer of Record

Bid No. 100423-Attachment to Addendum No.1


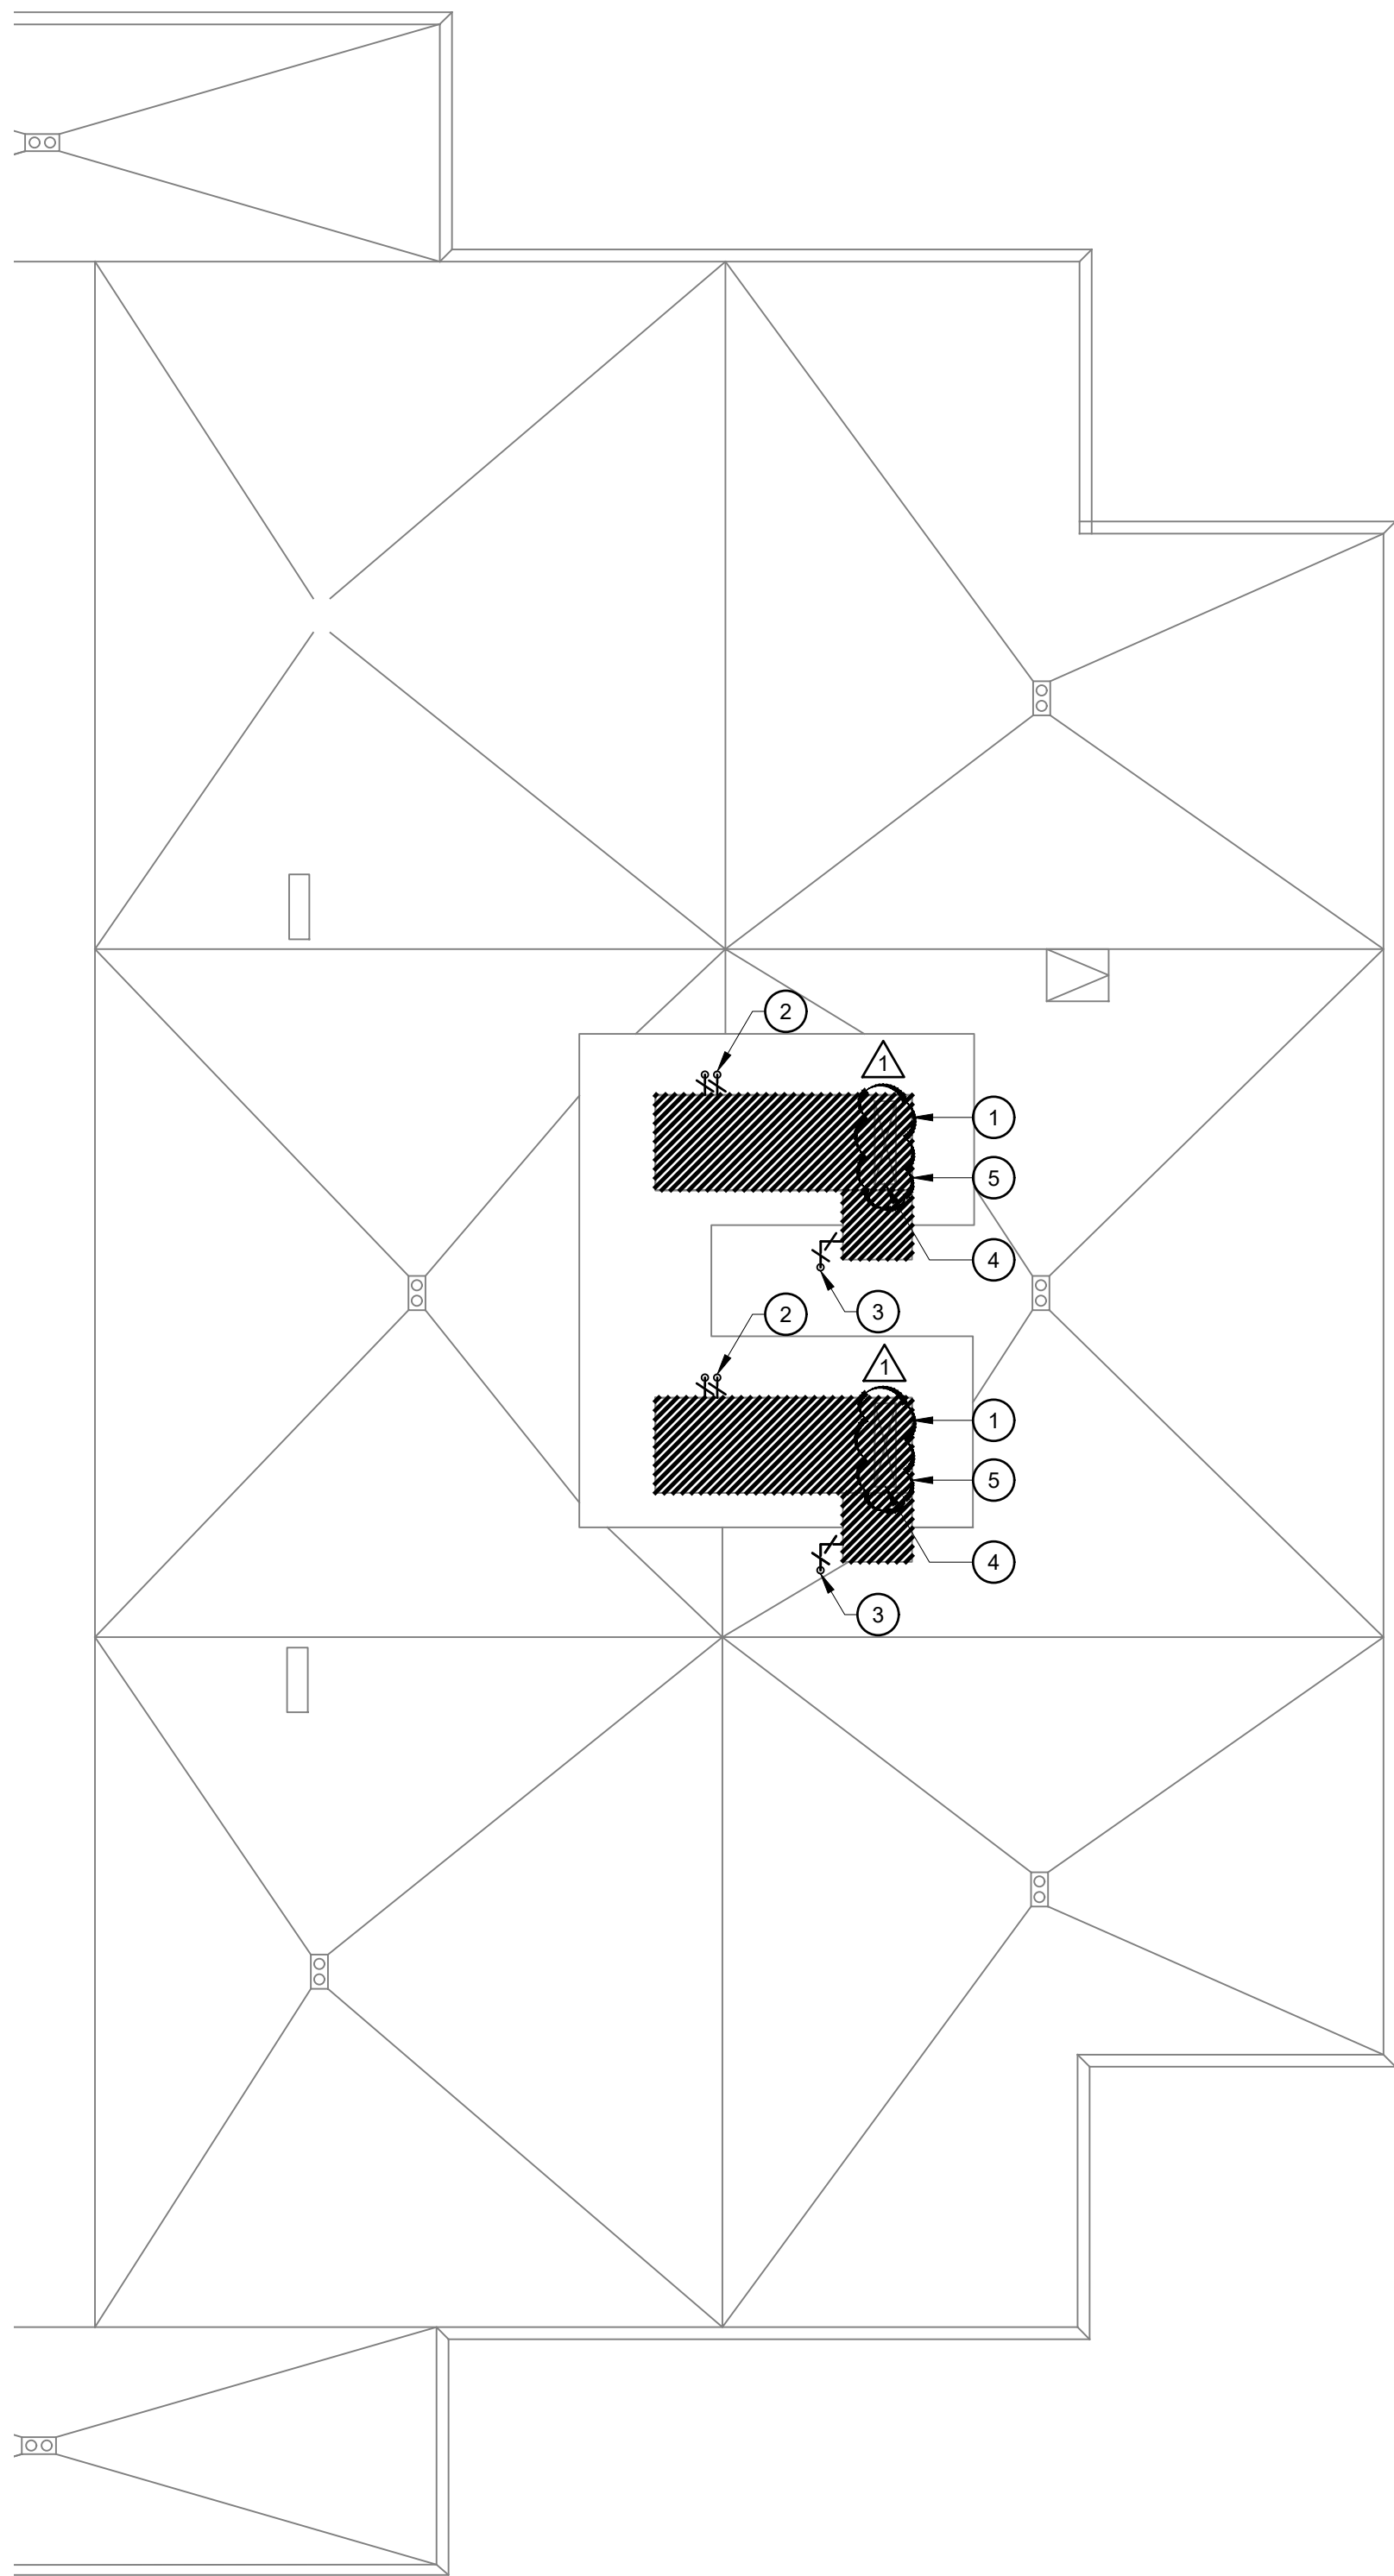


ENLARGED MECHANICAL DEMO ROOF PLAN

1/8" = 1'-0"

4

Bid No.100423-Atachmentnt to Addendum No.1

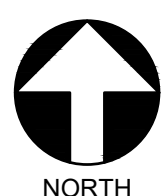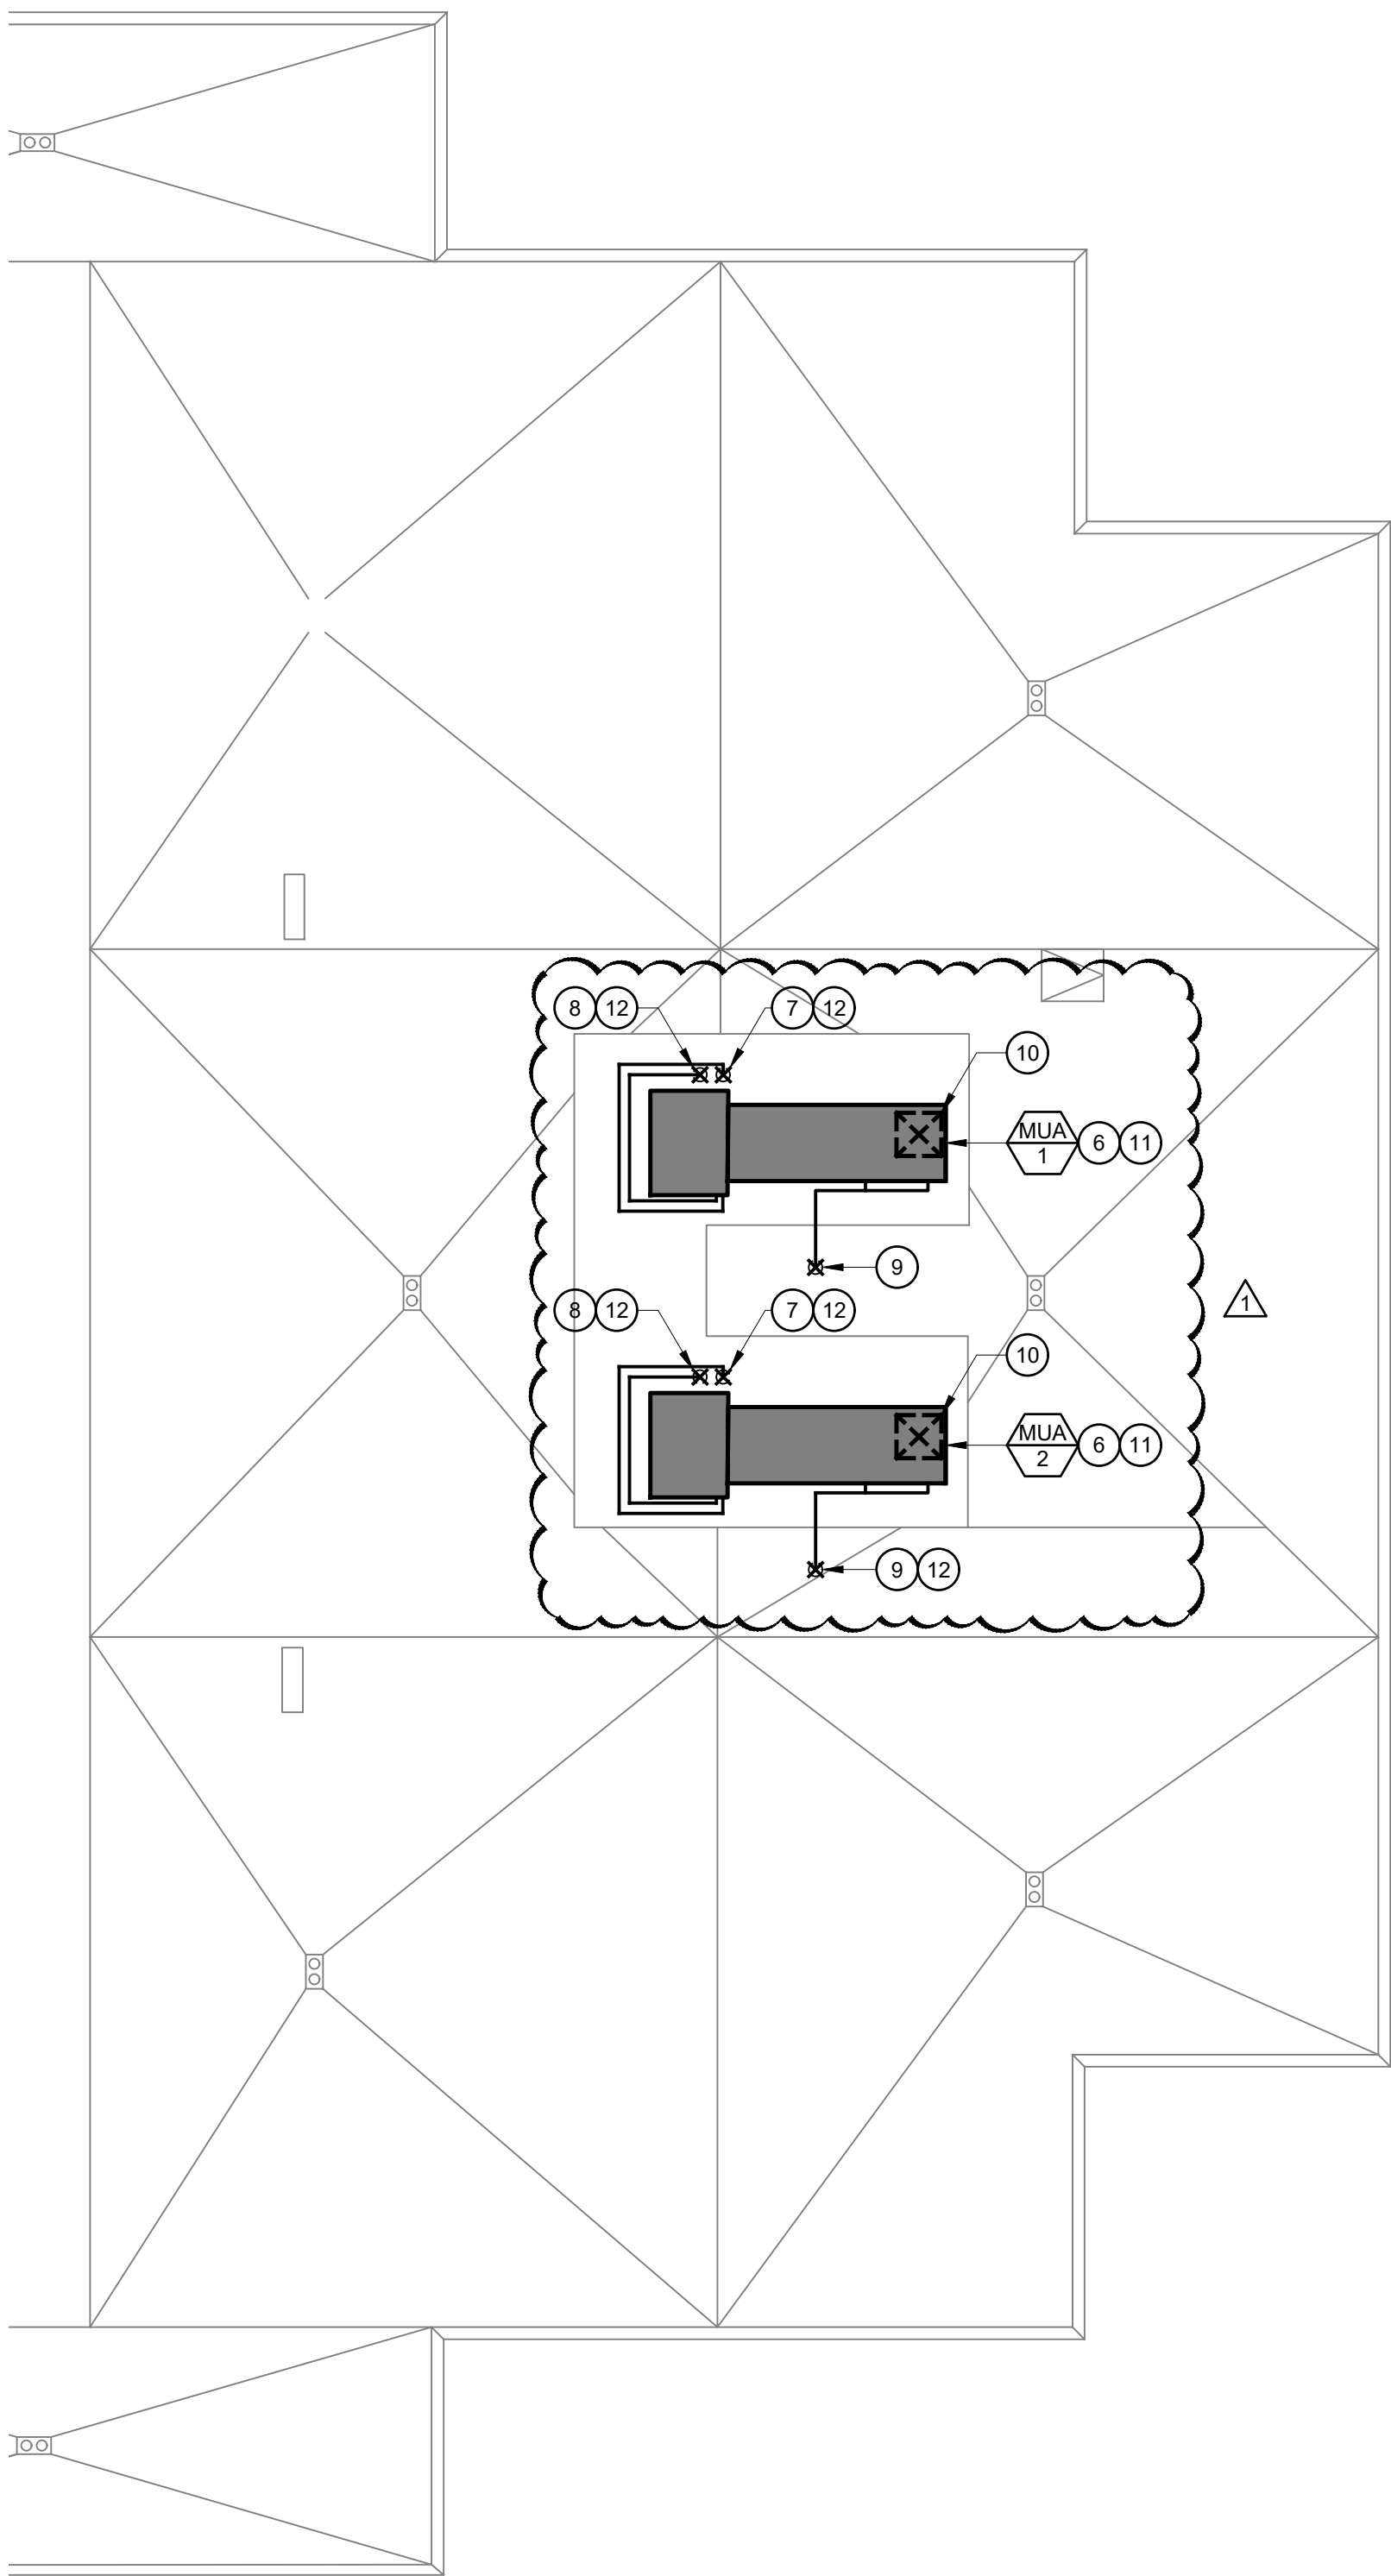


ENLARGED MECHANICAL ROOF PLAN

1/8" = 1'-0"

2

KEYNOTES

1. REMOVE (E) MUA UNIT AND PRESERVE (E) CURB.
2. DISCONNECT AND CAP (E) CONDENSATE AND (E) CW IN PREPARATION FOR CONNECTION TO (N) MUA UNIT.
3. DISCONNECT AND CAP (E) GAS IN PREPARATION FOR CONNECTION TO (N) MUA UNIT.
4. PRESERVE (E) SA DUCT DROP IN PREPARATION FOR CONNECTION TO (N) MUA UNIT.
5. DISCONNECT (E) ELECTRICAL CONNECTIONS.
6. INSTALL (N) MUA UNIT ON (N) CURB ADAPTER PER DETAIL 1/M800.
7. RECONNECT (E) 3/4" CONDENSATE TO (N) 3/4" CONDENSATE CONNECTION ON MUA UNIT WITH (N) TRAP PER DETAIL 3/M800.
8. RECONNECT (E) 3/4" CW TO (N) 3/4" MUA UNIT. SEE DETAIL 4/M800 FOR MUA PIPING SCHEMATIC.
9. RECONNECT (E) 1-1/2" GAS TO (N) 1-1/2" GAS AND ROUTE TO (N) MUA UNIT. ROUTE 1-1/2" G FULL SIZE TO EACH OF THE TWO GAS INLETS ON (N) MUA AND TRANSITION TO 3/4" GAS CONNECTION AT (N) MUA UNIT. PROVIDE WITH (N) DIRT LEG PER DETAIL 2/M800 (TYP OF 2).
10. CONNECT (N) 26"x25" DUCT DROP TO (E) 48"x12" SA DUCT.
11. RE-CONNECT (N) MUA UNIT TO (E) ELECTRICAL POWER.
12. SUPPORT (N) PIPING EVERY 6' PER DETAIL 5/M800.

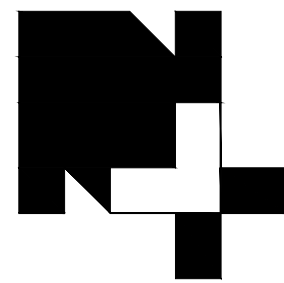

NET POSITIVE
consulting
engineers

www.NPCeng.com
559.940.7293

The ideas, drawings, designs and specifications incorporated herein serve as an instrument of services and is the property of Net Positive Consulting Engineers, Inc. and is not to be copied, reproduced, or distributed without the written authorization of Net Positive Consulting Engineers, Inc.



REVISIONS:

Symbol	Description
Δ	ADDENDUM 1
10/11/23	
Symbol	Description
---	---
Symbol	Description
---	---

PROJECT NAME:

MADERA USD
DESMOND MIDDLE SCHOOL
LOCKER ROOM HVAC

26480 MARTIN ST. MADERA, CA 93638

PROJECT NO. 1334

DATE:


SHEET TITLE:


DEMO AND NEW
ROOF PLAN

SHEET NO:

M501

AD01-01

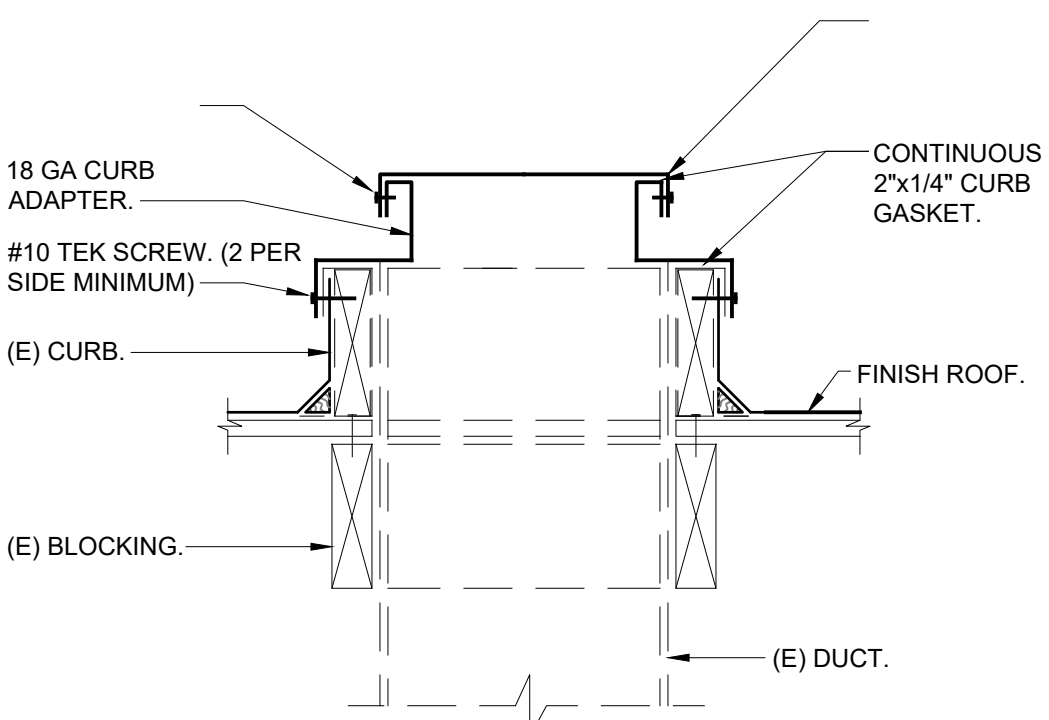								
	26	21	16	11	6	CURB ADAPTER	NTS	1
	27	22	17	12	7	GAS DIRT LEG	NTS	2
	28	23	18	13	8	CONDENSATE DRAIN CONNECTION	NTS	3
	29	24	19	14	MUA UNIT PIPING SCHEMATIC			4
	30	25	20	15	10	PIPE SUPPORT - ON ROOF	NTS	5

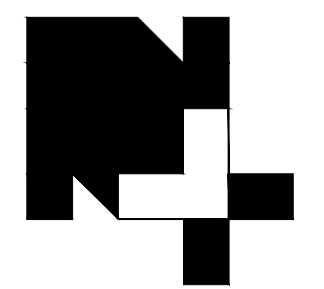

NET POSITIVE
consulting
engineers

www.NPCeng.com
559.940.7293

The ideas, drawings, designs and specifications incorporated herein serve as an instrument of services and is the property of Net Positive Consulting Engineers, Inc. and is not to be copied, reproduced, or distributed without the written authorization of Net Positive Consulting Engineers, Inc.



REVISIONS:	
Symbol	Description
	ADDENDUM 1
10/11/23	
Symbol	Description
---	---
Symbol	Description
---	---

PROJECT NAME:

**MADERA USD
DESMOND MIDDLE SCHOOL
LOCKER ROOM HVAC**

26490 MARTIN ST. MADERA, CA 93638

PROJECT NO. 1334

DATE:

SHEET TITLE:

**MECHANICAL /
PLUMBING
DETAILS**

SHEET NO:

M800

AD01-01